

2751, S. OCEAN DRIVE, HOLLYWOOD, FL 33019

## FLORIDA

## SCOPE OF WORK


1. PERFORM DEMOLITION AS PER THE PLANS ON THE EXISTING ROOF
2. CONSTRUCT NEW ADDITION AS PER THE PLANS

DRAWING

## DRAWING INDEX

- 5-1 SITE LOCATION LAYOUT & GENERAL NOTES
- 5-2 EXISTING BATHROOM LAYOUT PLAN
- 5-3 BATHROOM DEMOLITION LAYOUT PLAN
- 5-4 BATHROOM NEW CONSTRUCTION LAYOUT PLAN
- 5-5 NEW SAUNA CONSTRUCTION LAYOUT PLAN
- 5-6 BATHROOM ELECTRICAL LAYOUT PLAN

- 5-6 BATHROOM ELECTRICAL LAYOUT PLAN

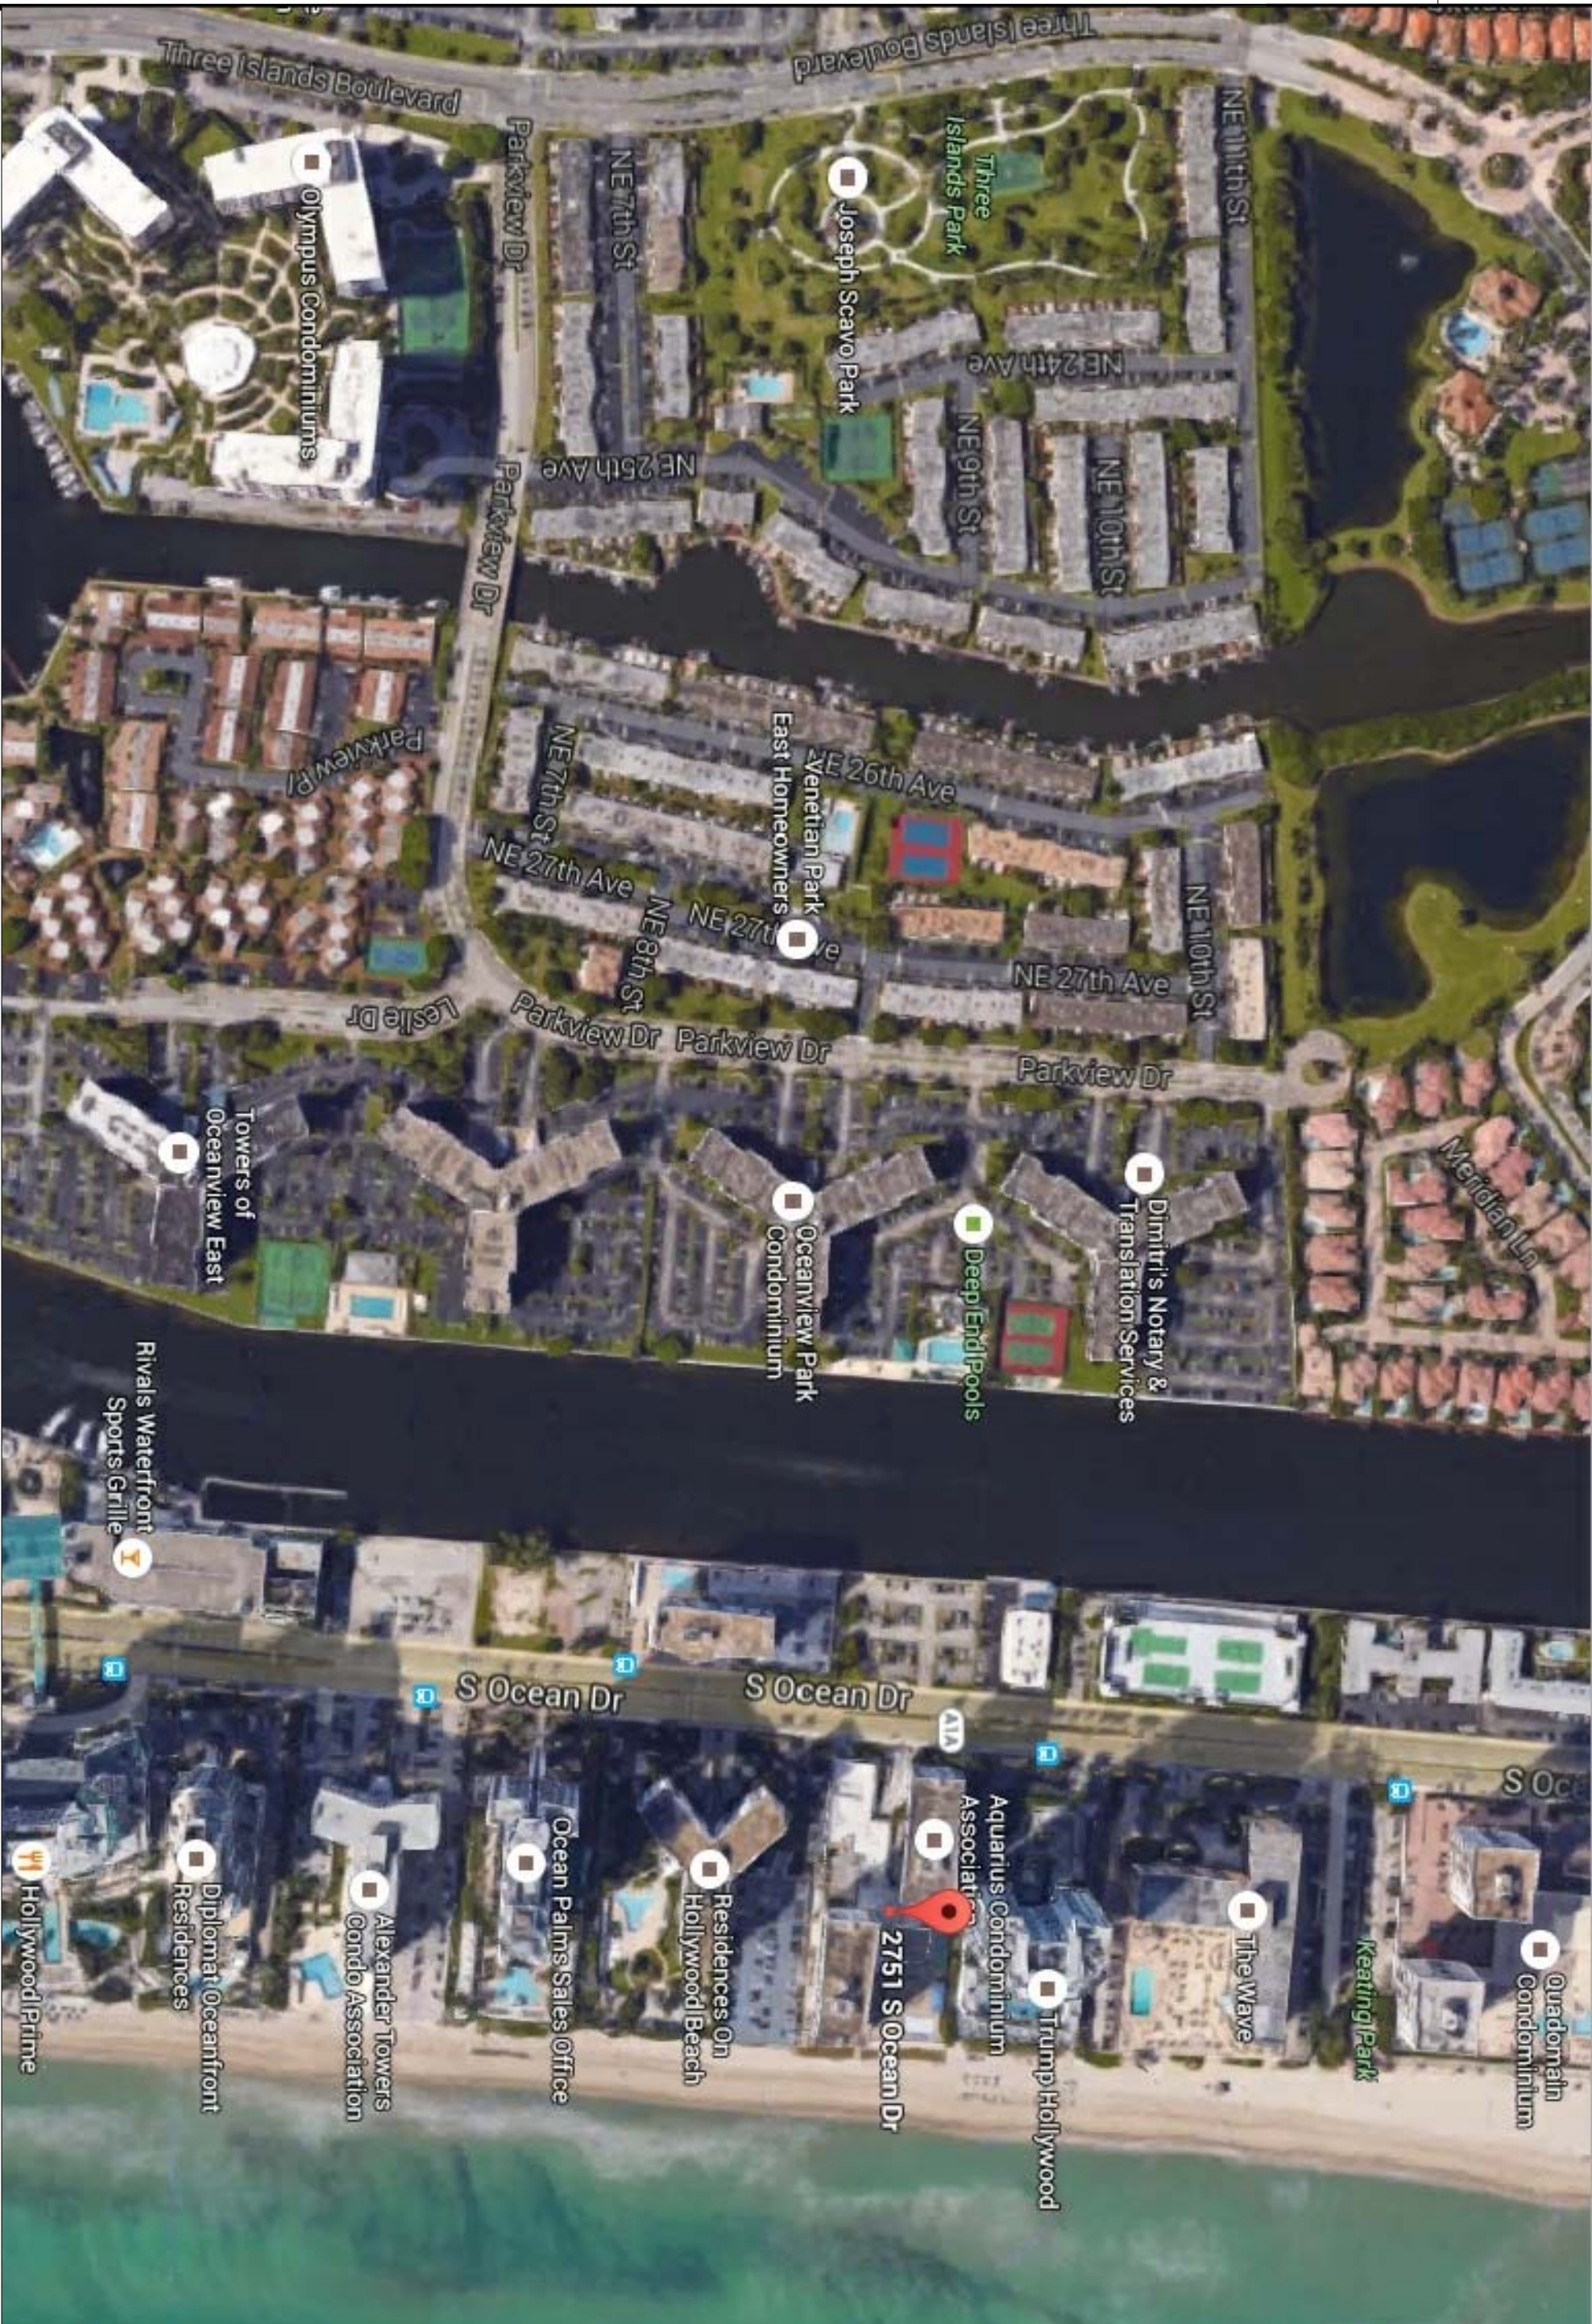

## NORTH

SCALE: 1/8"=1'-0"

Date: 04/10/2016  
Drawn: NAD  
Revised: NAD

Job  
1508

Drawing No

5-1

See

FARRUKH SAYEED  
DOI: 10.4236/2014.44001

## EXISTING BATHROOM RENOVATION: AQUARIUS CONDOMINIUMS ASSOCIATION

2751. SOUTH OCEAN DRIVE, FLORIDA

S&D Engineering and Construction, Inc.

3107 N.W. 71st. Ave.  
Margate, Florida 33063  
QB# 52647 COA# 28388

Tel: (954) 775-0143  
Fax: (754) 229-8400