



NOTE: "TO DEMOLISH"
REMOVE EXISTING FLOOR TILES
REMOVE EXISTING WALL TILES
REMOVE COUNTERTOP & SINKS
REMOVE URINAL & TOILETS
REMOVE PLUMBING FIXTURES
REMOVE TOILET PARTITIONS
REMOVE EXISTING WALL BOARDS
SAUNA WOOD TO REMAIN
REMOVE INTERIOR DOORS

NOTE: "TO REMAIN"
EXISTING PLUMBING AND FLOOR
DRAINS TO REMAIN AS IS
EXISTING ELECTRICAL TO REMAIN
AS IS
EXISTING MECHANICAL TO REMAIN
AS IS
EXISTING DRY SAUNA WOOD TO
REMAIN

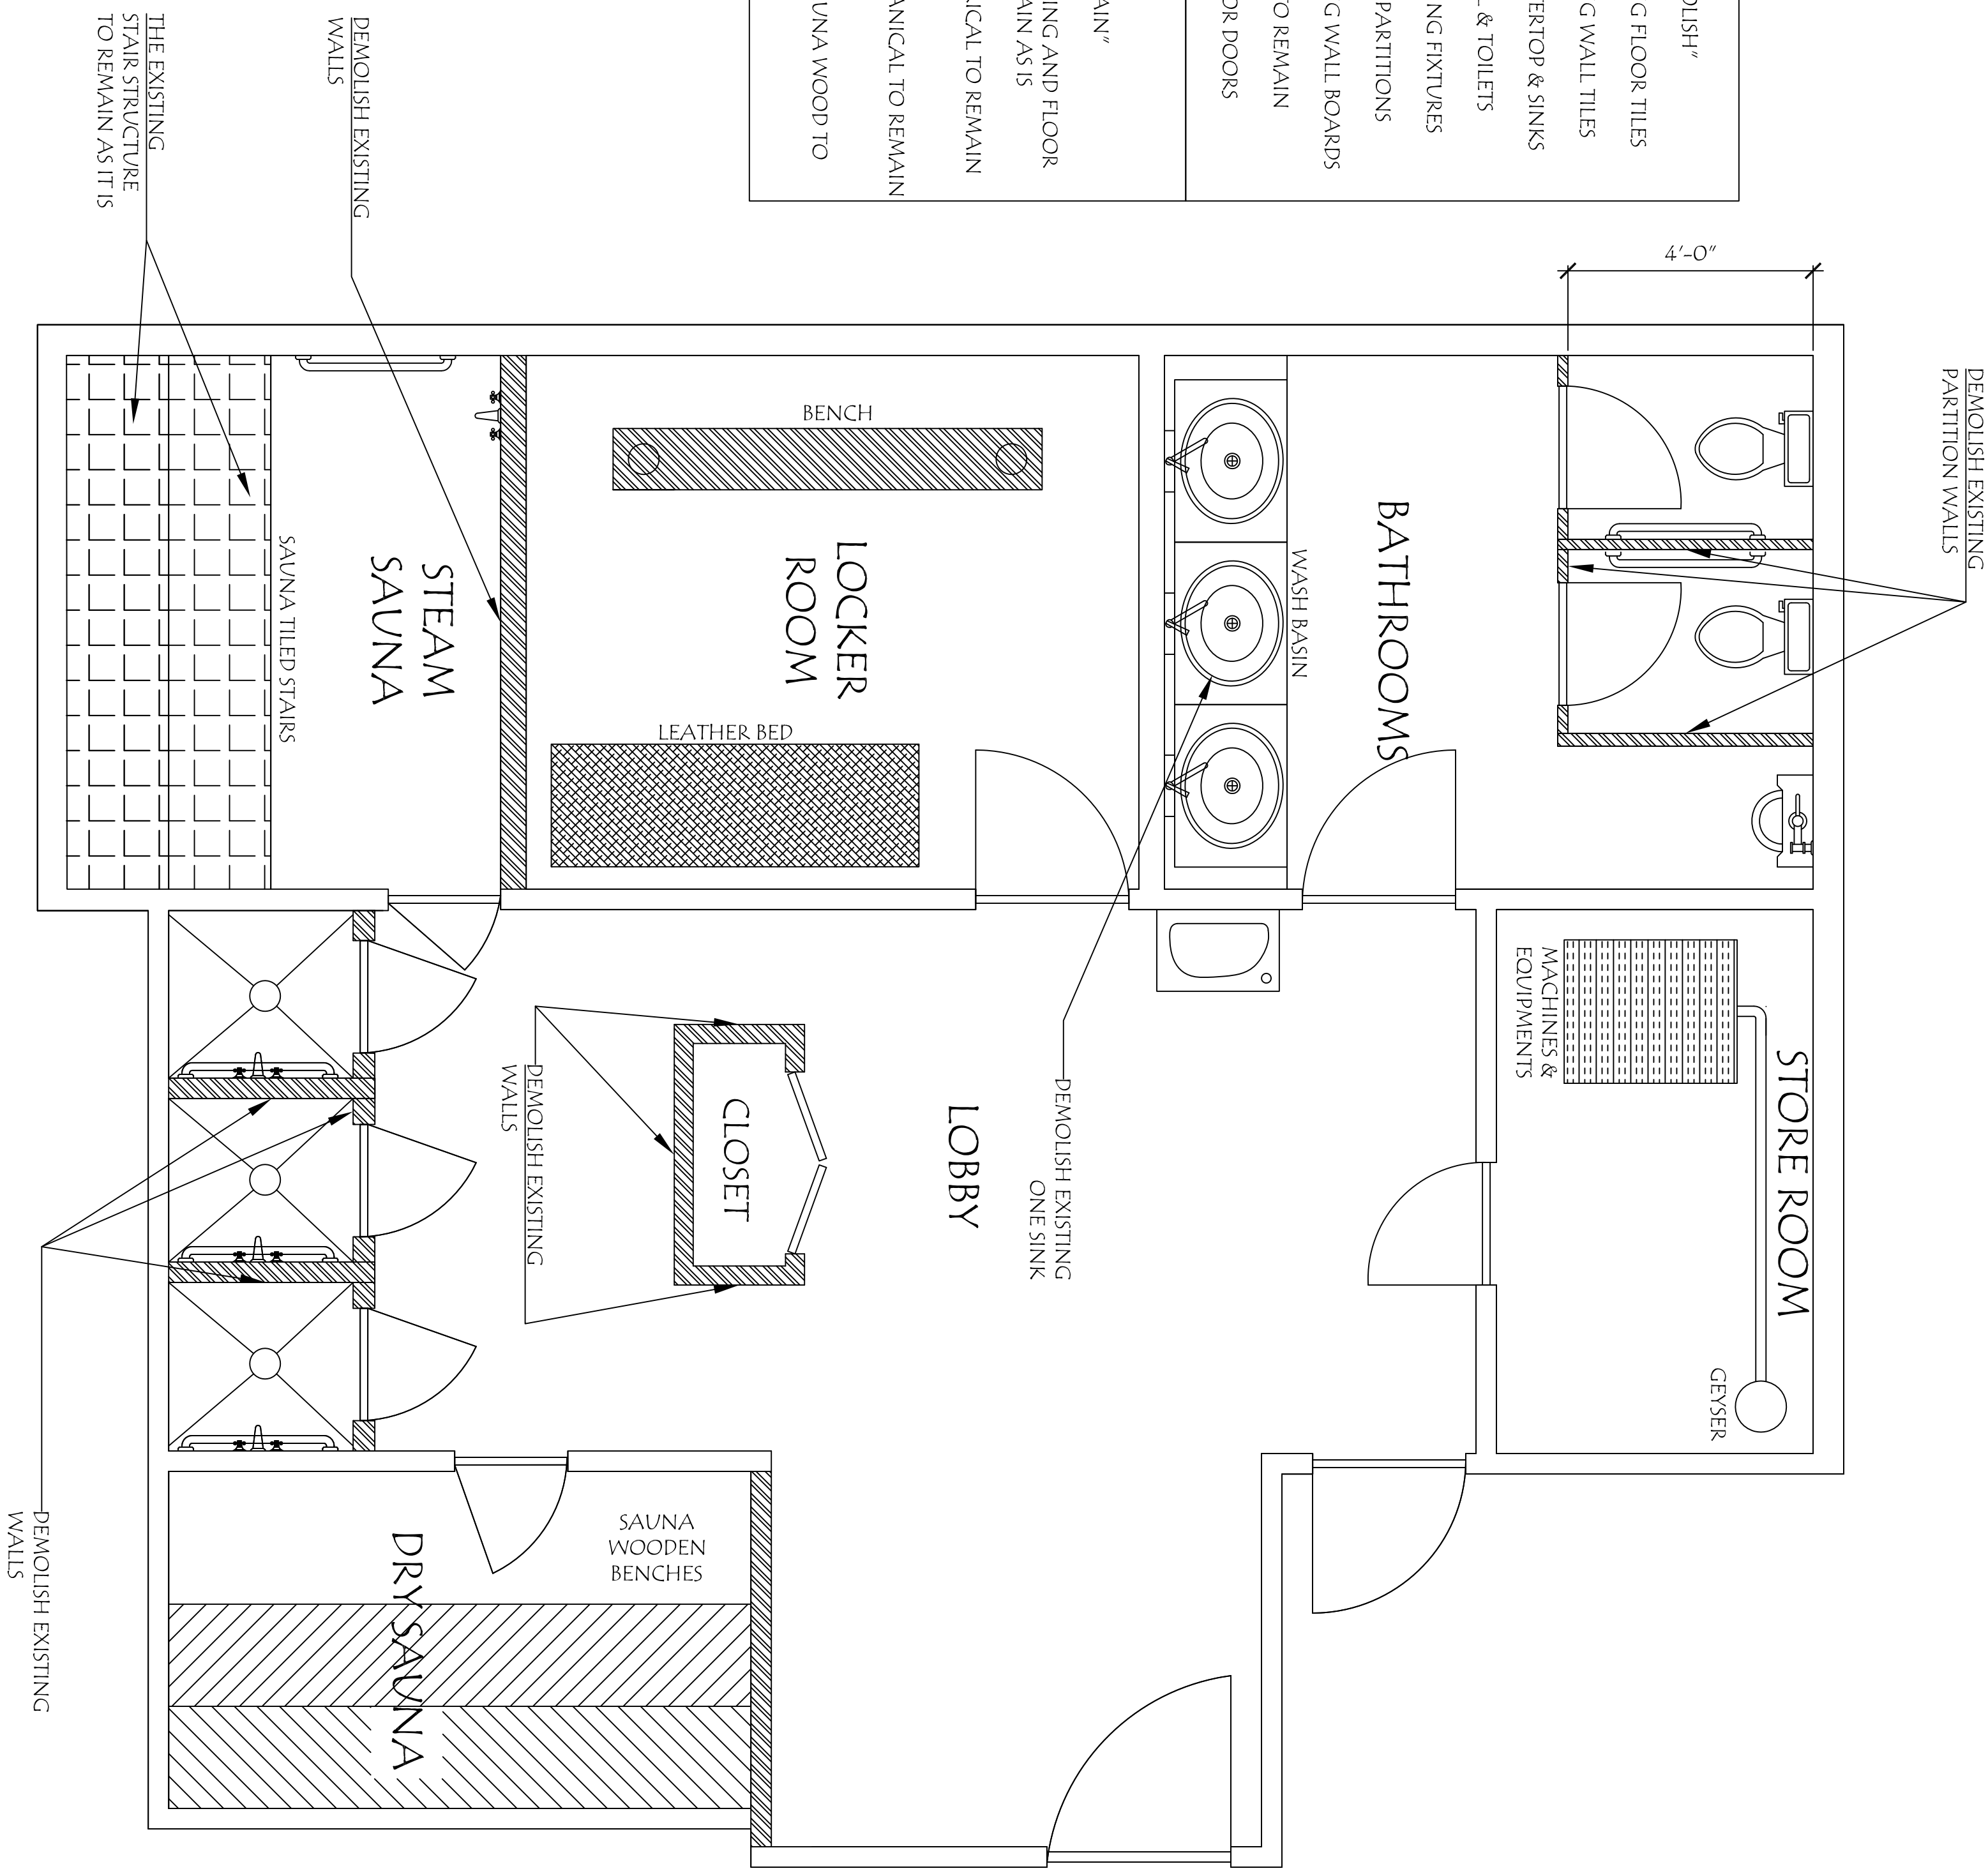

BATHROOM DEMOLITION LAYOUT

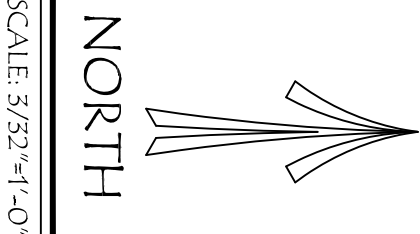

Seal

FAROUKH SAYED
P# 64701

Date: 04/10/2016
Drawn: NAD
Revised: NAD
Revision: 1

Job No.
15084

Drawing No.

S-3

EXISTING BATHROOM RENOVATION:
AQUARIUS CONDOMINIUMS ASSOCIATION
2751, SOUTH OCEAN DRIVE, FLORIDA

S&D Engineering and Construction, Inc

3107 N.W. 71st. Ave.
Margate, Florida 33063
QB# 52647 COA# 28388

Tel: (954) 775-0143
Fax: (754) 229-8401